



LUMINAIRE SCHEDULE								
TYPE	DESCRIPTION	SOURCE	LUMENS	CCT	VOLTS	WATTS	MOUNTING/HEIGHT	MANUFACTURER/MODEL
L1	LED AREA LUMINAIRE POLE MOUNTED FIXTURE - DOUBLE HEAD	LED	19786	3000K	120	171	POLE MOUNTED 20FT	MFG: LITHONIA LIGHTING CAT: DSX0-LED-P7-30K-T4M
L2	LED AREA LUMINAIRE POLE MOUNTED FIXTURE - WITH HOUSE SIDE SHIELD	LED	3524	3000K	120	33	POLE MOUNTED 10FT	MFG: LITHONIA LIGHTING CAT: DSX0-LED-P1-30K-3MHS
L3	LED AREA LUMINAIRE POLE MOUNTED FIXTURE	LED	8564	3000K	120	68	POLE MOUNTED 12FT	MFG: LITHONIA LIGHTING CAT: DSX0-LED-P3-30K-T4M
L4	LED WEDGE2 WALL SCONCE	LED	5774	3000K	120	48	WALL MOUNTED 16FT	MFG: LITHONIA LIGHTING CAT: WDGE2-LED-P5-30K-VF
L5	LED ROUND SURFACE MOUNTED LIGHT	LED	1089	3000K	120	14	SURFACE MOUNT	MFG: LIGHTQUIR, SIGNIFY CAT: STR930K10
L6	LED WEDGE2 WALL SCONCE	LED	4376	3000K	120	40	WALL MOUNTED 12FT	MFG: LITHONIA LIGHTING CAT: WDGE2-LED-P4-30K-T4M
B1	LED BOLLARD LIGHTING	LED	1063	3000K	120	20	3FT	MFG: LANDSCAPE FORMS CAT: AP-012LS-03SF-30K
B2	LED LANDSCAPE LIGHTING	LED	1864	3000K	120	42	8FT	MFG: LANDSCAPE FORMS CAT: AP-101-S0-30K-FRS

NOTES	
1.	ALL EXTERIOR LIGHTING TO BE FULL CUT-OFF AND DARK SKY COMPLIANT.
2.	ALL EXTERIOR LIGHTING TO BE CONTROLLED BY TIME-CLOCK AND PHOTOCCELL.
3.	ALL LIGHT LEVELS SHOWN ARE IN FOOTCANDLES AT GRADE LEVEL.
4.	ALL LIGHT FIXTURES TO HAVE BI-LEVEL DIMMING TO LIMIT OUTPUT TO 2000LUMENS AFTER 11PM TO SUIT CITY BY-LAW.

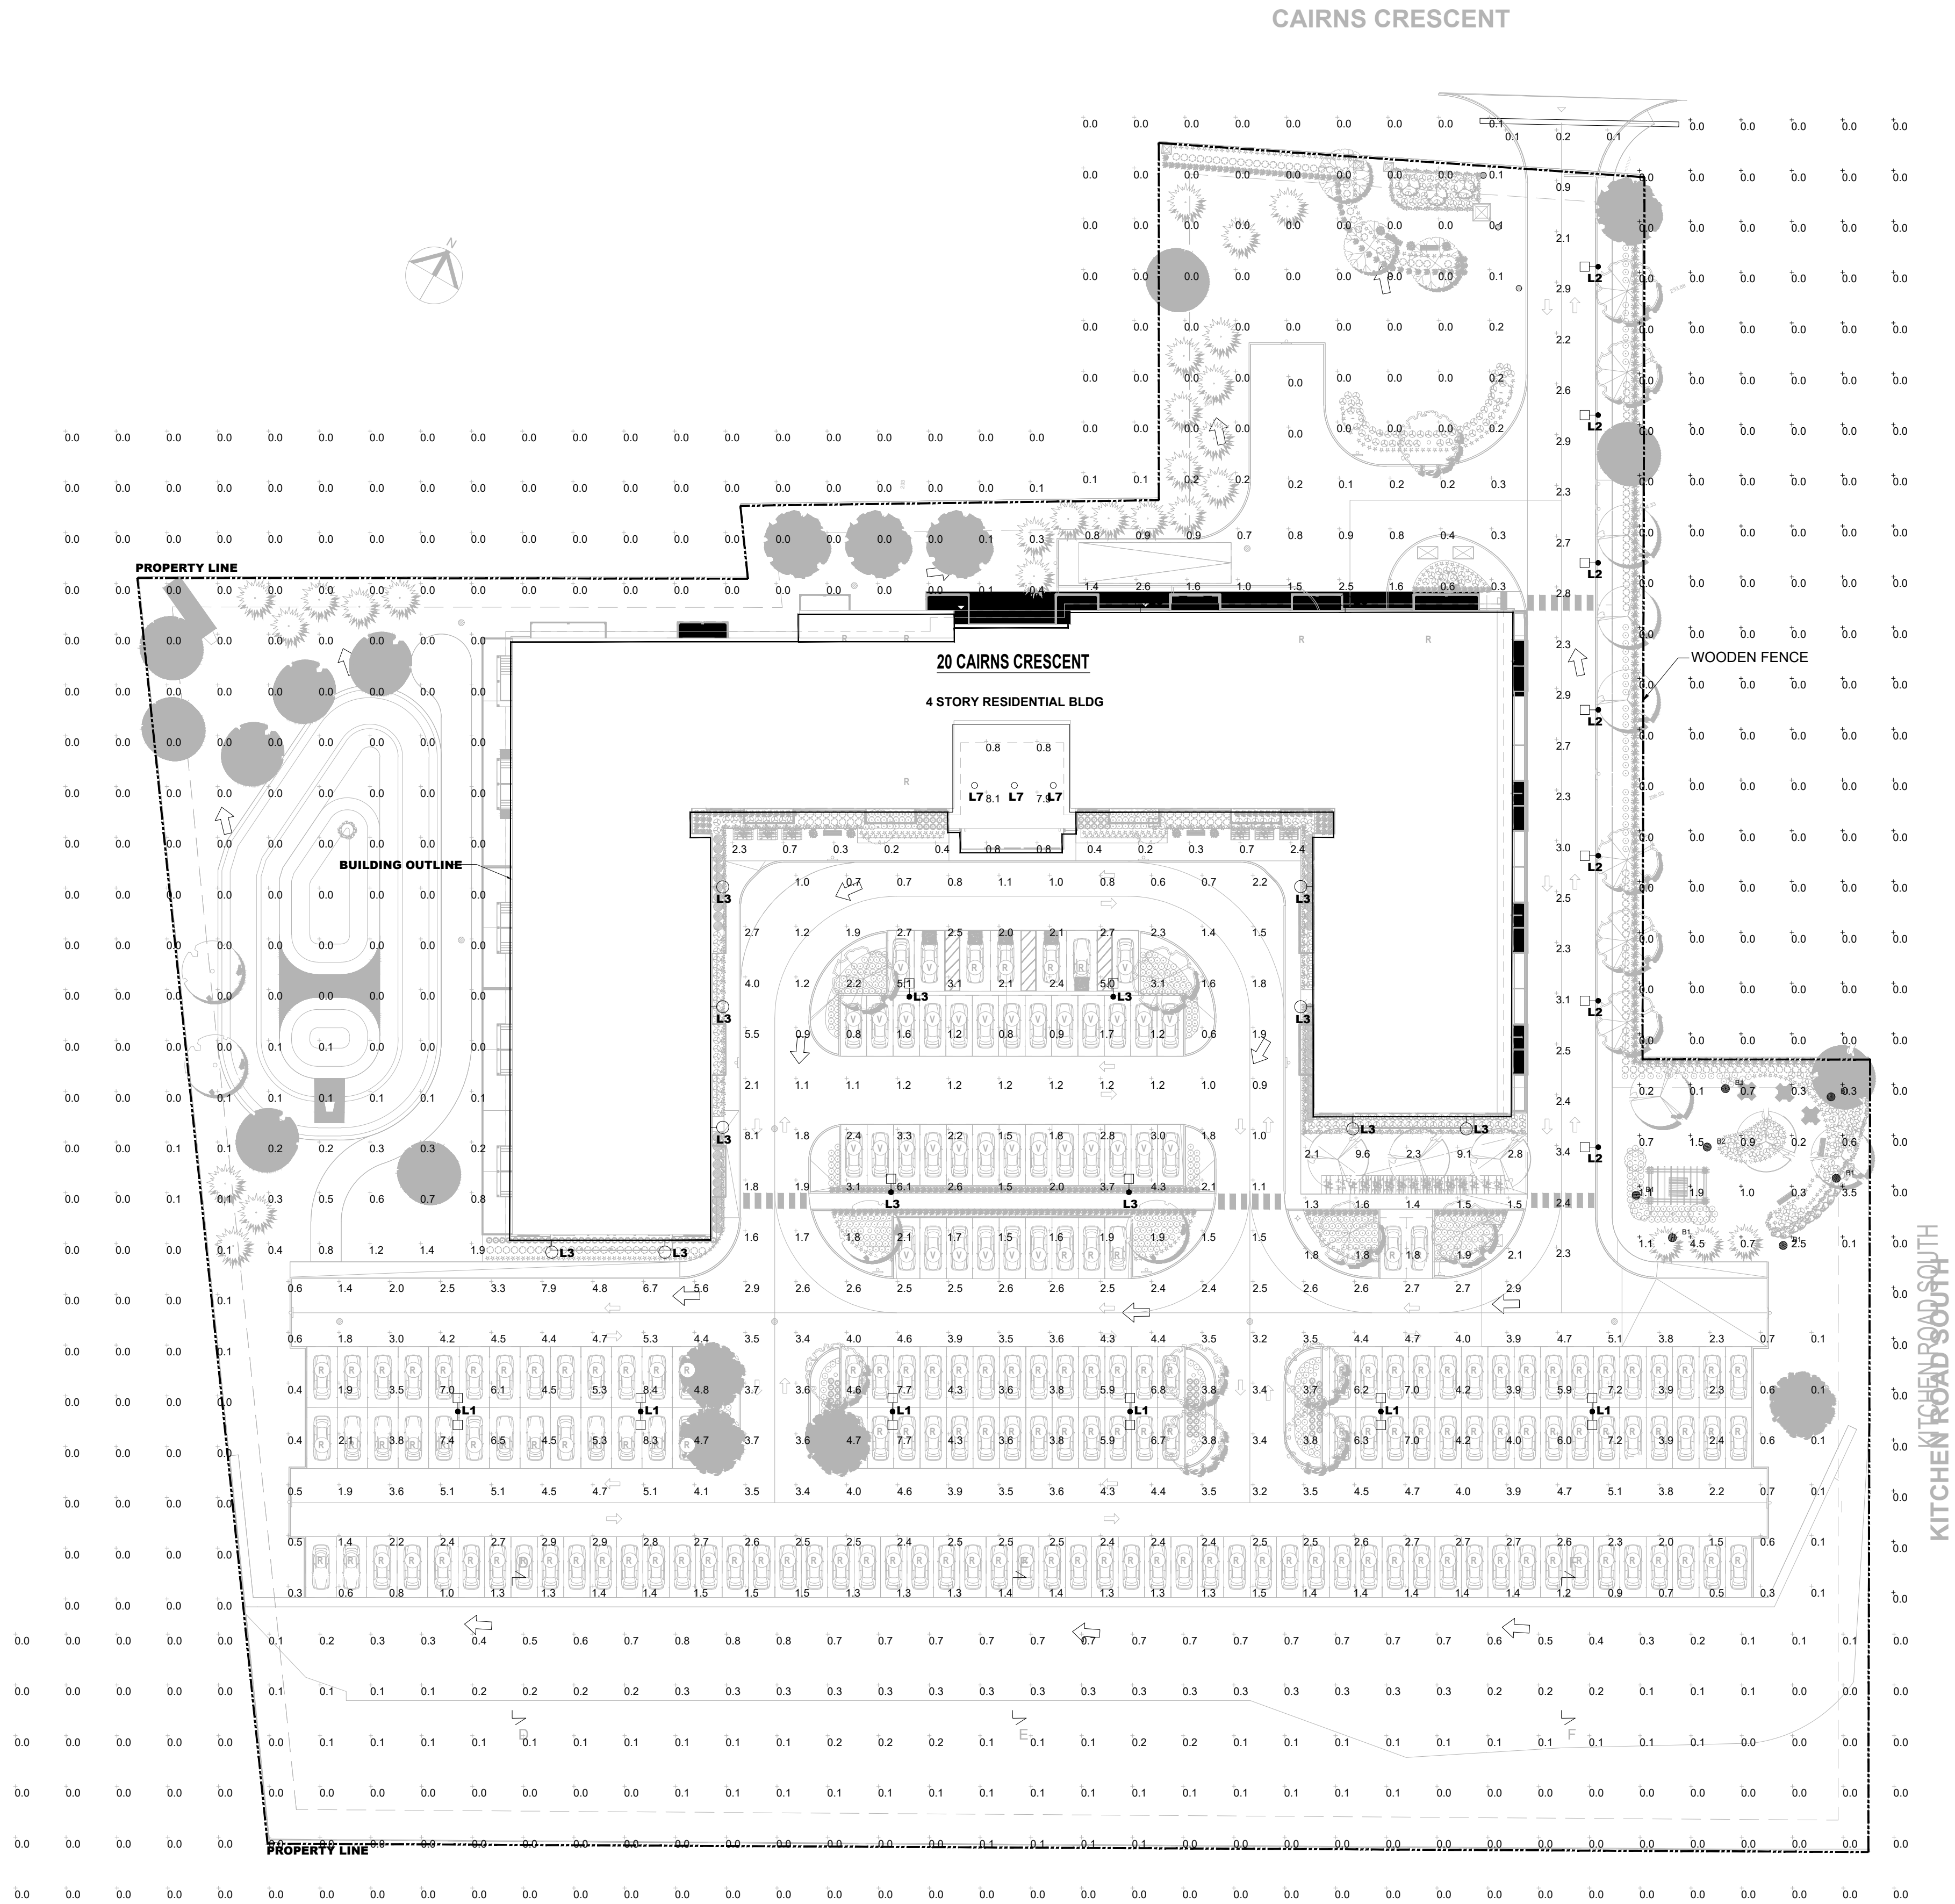


DO NOT SCALE DRAWINGS. OBTAIN INFORMATION INVOLVING ACCURATE DIMENSIONS TO STRUCTURE FROM DIMENSIONS SHOWN ON ARCHITECTURAL AND STRUCTURAL DRAWINGS, OR BY SITE MEASUREMENTS. SITE PLAN LAYOUT TO BE OBTAINED FROM ARCHITECT OR CIVIL ENGINEER. CONSULT GENERAL CONSTRUCTION DRAWINGS AS WELL AS DETAIL DRAWINGS TO BECOME FAMILIAR WITH ALL CONDITIONS AFFECTING THE WORK, AND VERIFY SPACES IN WHICH THE WORK WILL BE INSTALLED.

4	RE-ISSUED FOR SPA	2025-08-18	JC
3	RE-ISSUED FOR SPA	2025-07-24	JC
2	FOR FIRST CLASS 3 MAJOR CPP SUBMISSION	2024-11-11	JC
1	ISSUED FOR COORDINATION	2024-04-15	UQ
NO.	ISSUED FOR	DATE	BY

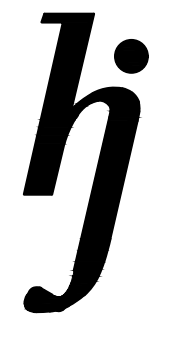

HAMMERSCHLAG & JOFFE INC.
43 Lesmill Road, Toronto, Ontario
Canada M3B 2T8
T: (416) 444.9263
F: (416) 444.1463
E: dwg@hamjof.com

STAMP:

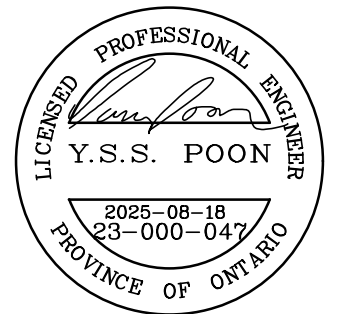

PROJECT:
RESIDENTIAL APARTMENT
OWNER: 1000120857 ONTARIO INC.
20 Cairns Crescent, Huntsville, Ontario

TITLE:
SITE LIGHTING PLAN

PROJECT NO.: 23-000-047

DATE: MARCH 2024 DRAWN BY: UQ

SCALE: 1:400 CHK'D BY: SP

SHEET NO.: